


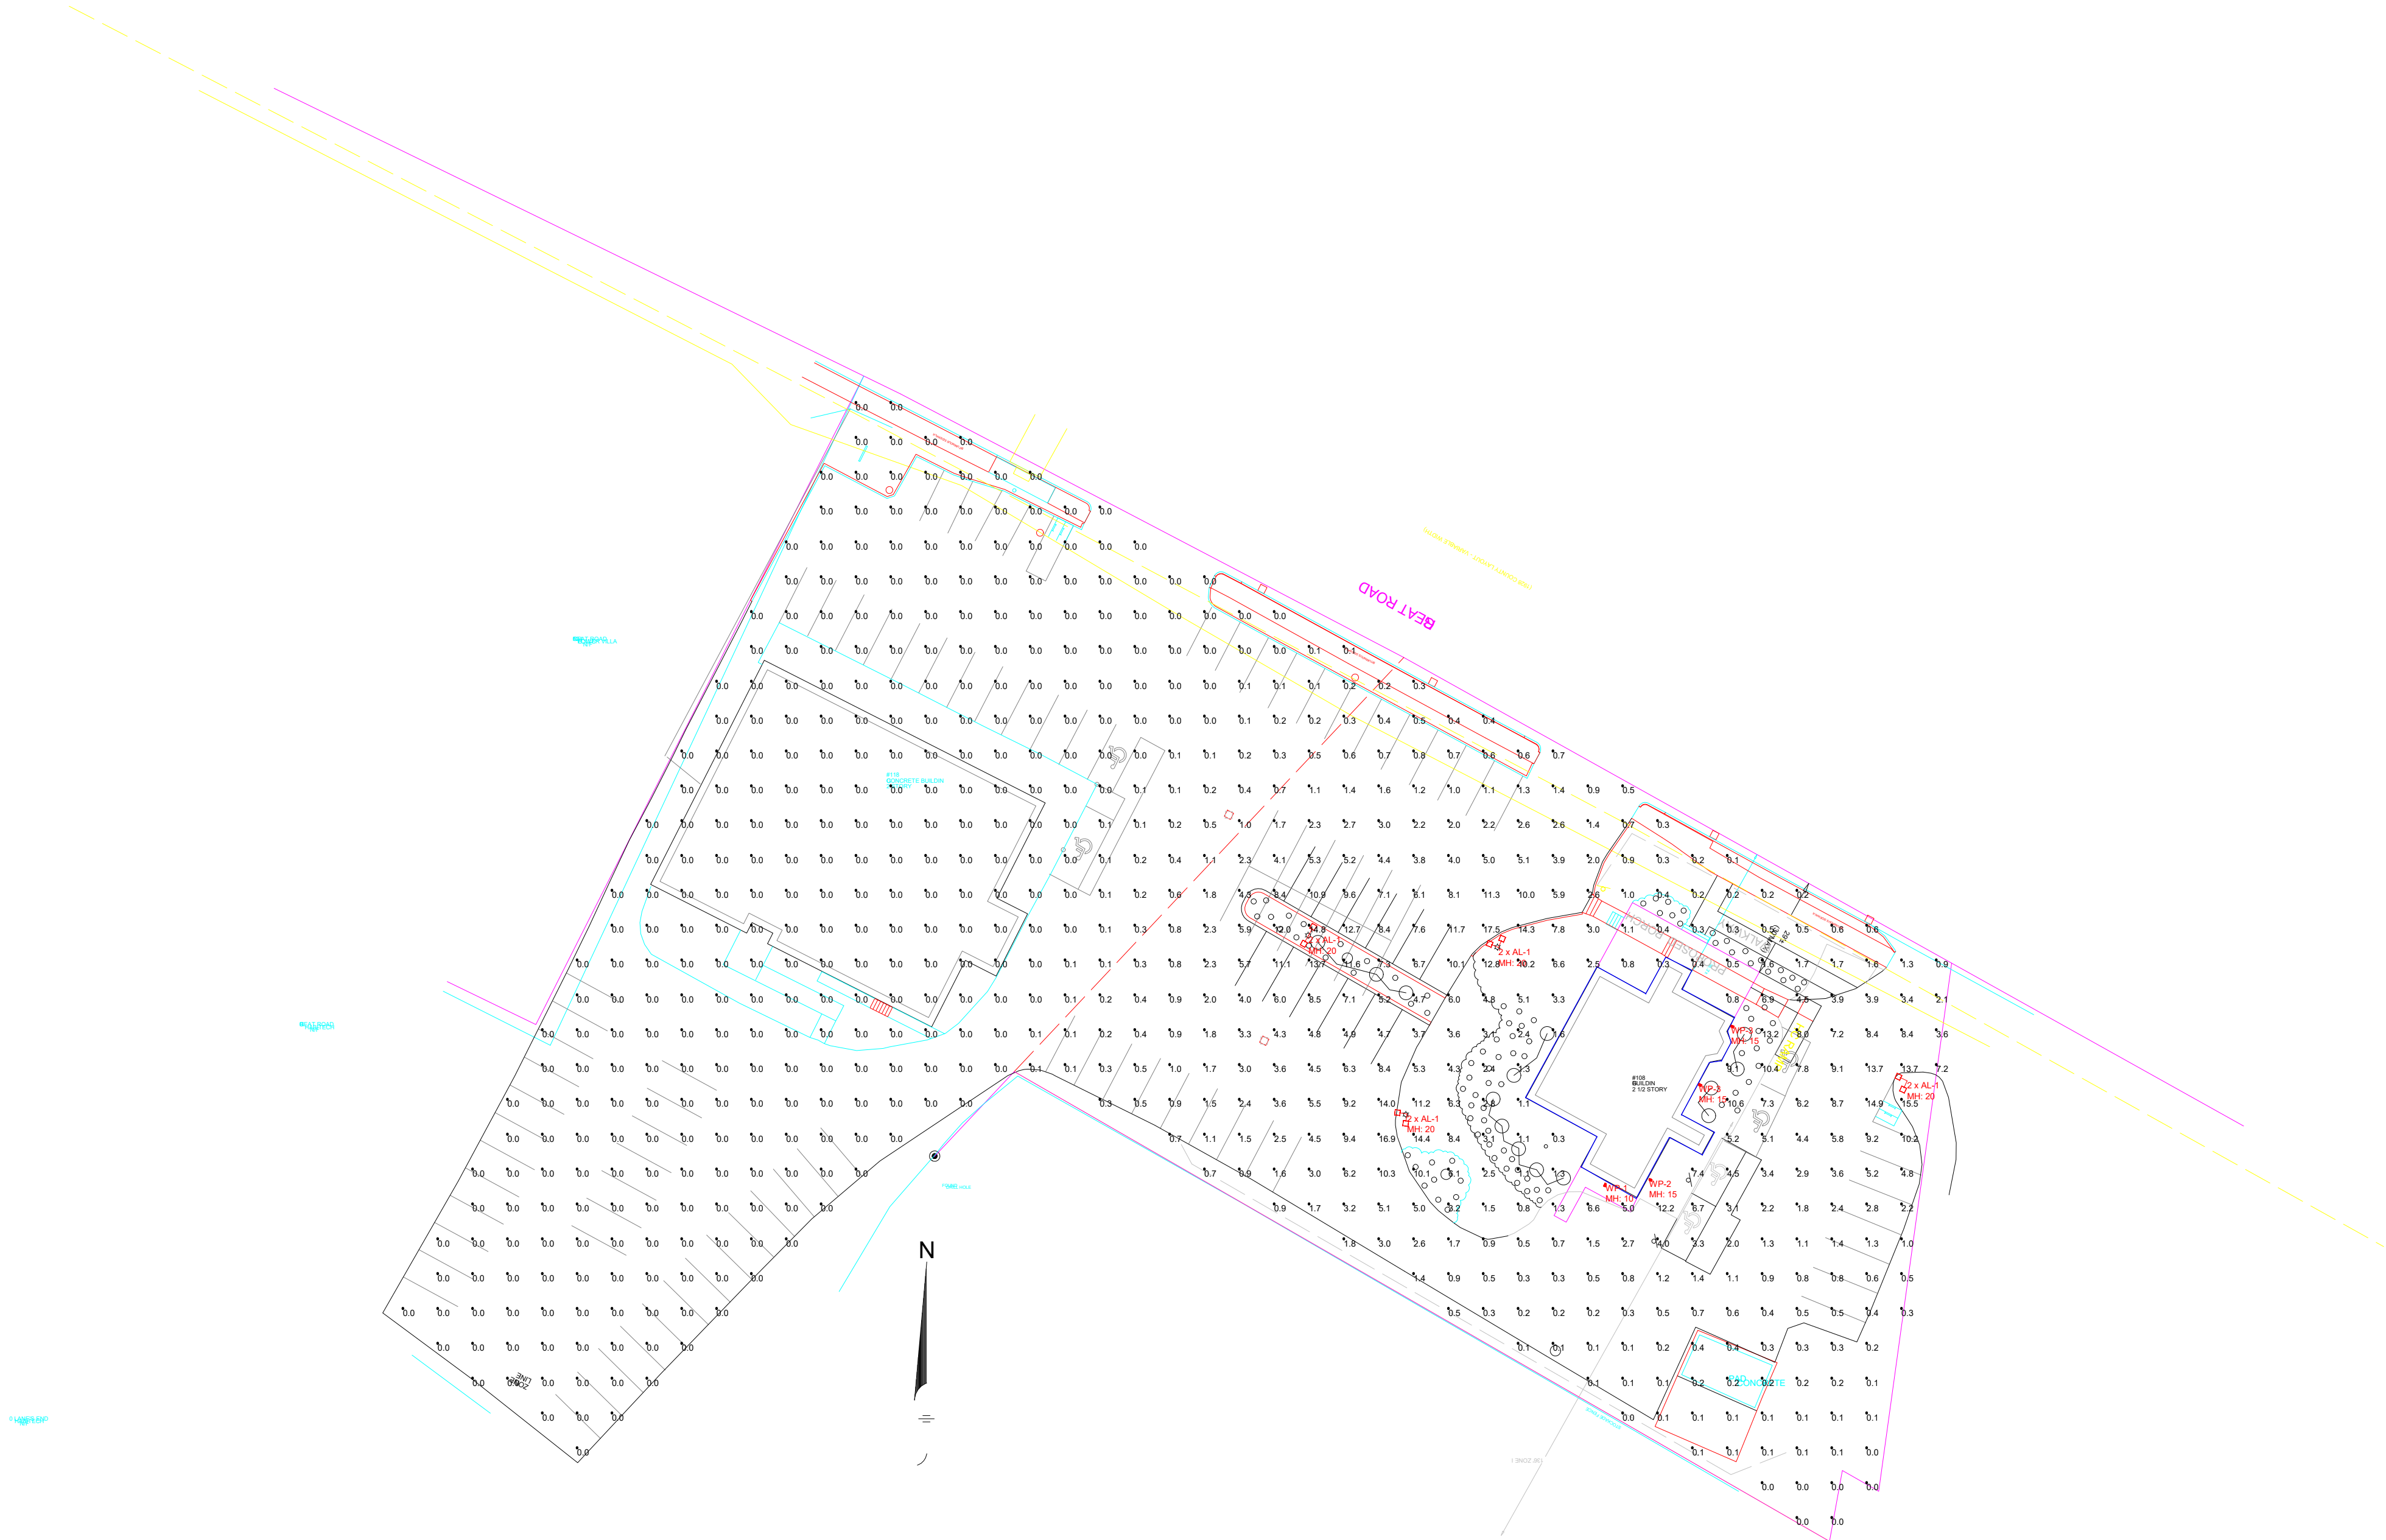

Luminaire Schedule									
Symbol	Qty	Label	Tag	LLF	Luminaire Lumens	Luminaire Watts	Total Watts	Mounting Height	Arrangement
	1	JWP-FC-CPS-80W	WP-2	0.950	9865	82.12	82.12	15	Single
	2	JWP-FC-CPS-64W	WP-3	0.950	8960	64	128	15	Single
	1	Jademar JWP-NCS-30W	WP-1	0.950	3372	28.24	28.24	10	Single
	1	JD-SB-100W-40K-T4 1	2 x AL-1	0.950	14032	101.3	202.6	20	Back-Back
	3	JD-SB-100W-40K-T4	2 x AL-1	0.950	14032	101.3	607.8	20	2 @ 90 degrees

#	Date	Comments
Revisions		

Drawn By: David J Hammel LC	
Checked By:	
Date: 11/22/2023	
Scale:	

108 Great Rd.	
	Site Lighting Plan v2