

COTTAGES AT WANDERING POND


STOW, MASSACHUSETTS

SITE LIGHTING PLANS

LIST OF DRAWINGS:

		SET DATE
L3.1	SITE LIGHTING PLAN - SOUTH	5/3/23
L3.2	SITE LIGHTING PLAN - NORTH	5/3/23
L3.3	AMENITY AREA LIGHTING PLAN	5/3/23
L3.4	SITE LIGHTING SPECIFICATIONS	5/3/23

PREPARED BY:

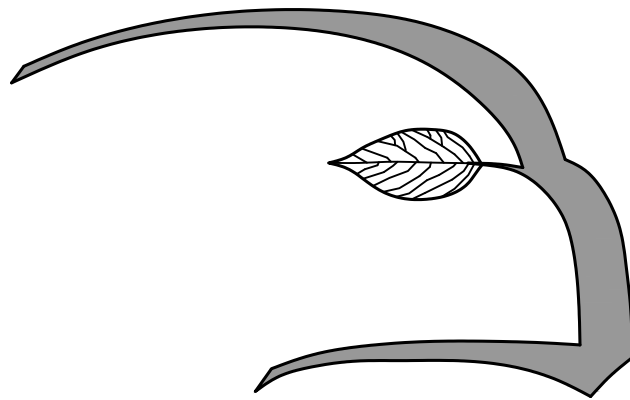

Hawk Design, Inc.
Landscape Architecture
Land Planning
Sagamore, MA
508-833-8800
info@hawkdesigninc.com

Matchline Sheet L2.2
Sheet L2.1


Sheet L3.2 Matchline
Sheet L3.1

See Sht. L3.3 -
Amenity Lighting Plan

Lighting Schedule


SYMBOL	QUANTITY	DESCRIPTION	MANUFACTURER	SPECIFICATION
☼	25	POST LIGHT	PEMCO	LEXINGTON (SPECIFICATION TBD)

0 80 160 240 feet
SCALE: 1" = 80'
Base plan information provided by Stamski and
McNary, Inc.

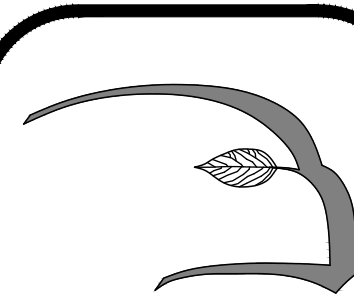

Hawk Design, Inc.
Landscape Architecture
Land Planning
Sagamore, MA
508-833-8800
info@hawkdesigninc.com
www.hawkdesigninc.com

HAWK DESIGN, INC. 2023
THIS DRAWING AND ALL INFORMATION CONTAINED
HEREON IS PROPRIETARY INFORMATION OF HAWK
DESIGN, INC. AND MAY NOT BE COPIED OR
REPRODUCED, EITHER IN WHOLE OR IN PART, BY
ANY METHOD, WITHOUT WRITTEN PERMISSION OF
HAWK DESIGN, INC.

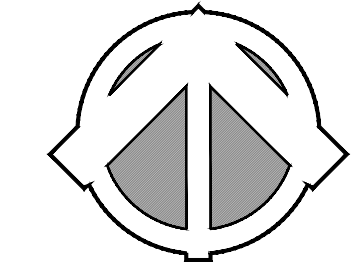

Date: 1/3/23

Revisions:		
Num.	Date	Description
1.	5/3/23	Site lighting plans and lighting specifications


Cottages at Wandering Pond
Athens Lane - Stow, MA

Drawn By: ND Checked By: TM

**Site Lighting
Plan - South**


Scale: 1" = 80'-0"

Sheet: **L3.1**

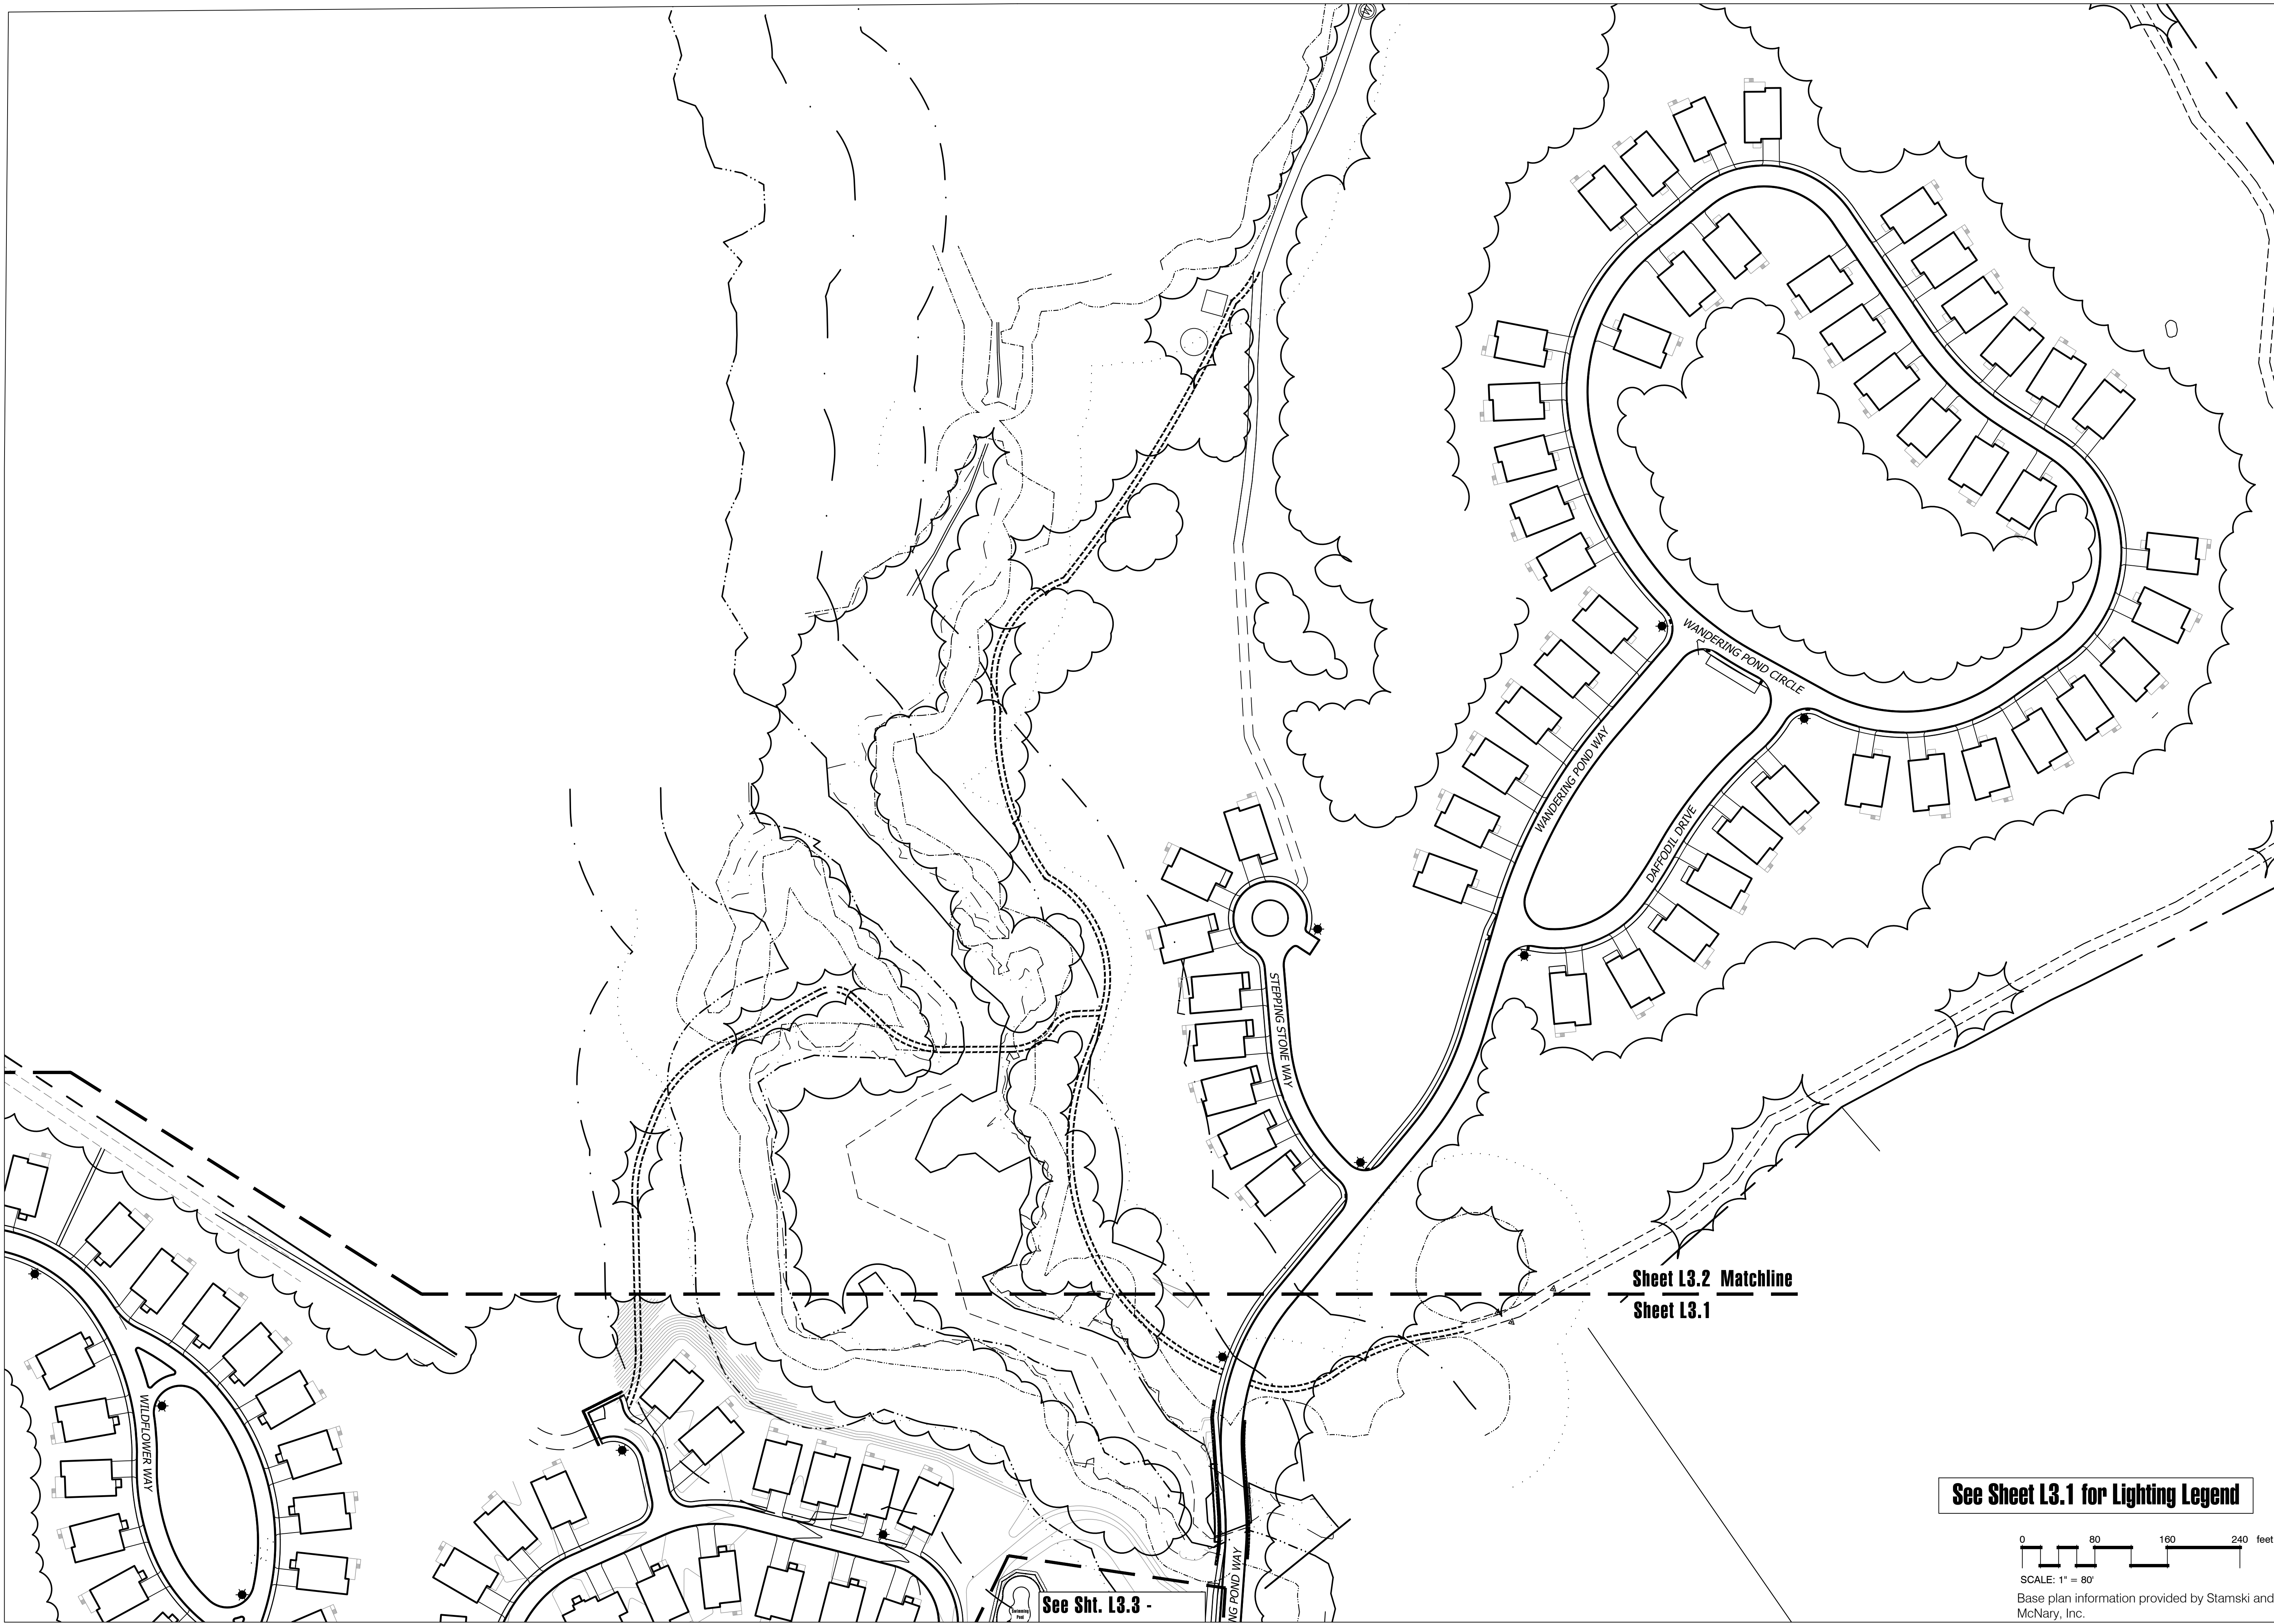

Hawk Design, Inc.
Landscape Architecture
Land Planning
Sagamore, MA
508-833-8800
info@hawkdesigninc.com
www.hawkdesigninc.com

HAWK DESIGN, INC. 2023
THIS DRAWING AND ALL INFORMATION CONTAINED
HEREON IS PROPRIETARY INFORMATION OF HAWK
DESIGN, INC. AND MAY NOT BE COPIED OR
REPRODUCED, EITHER IN WHOLE OR IN PART, BY
ANY METHOD, WITHOUT WRITTEN PERMISSION OF
HAWK DESIGN, INC.

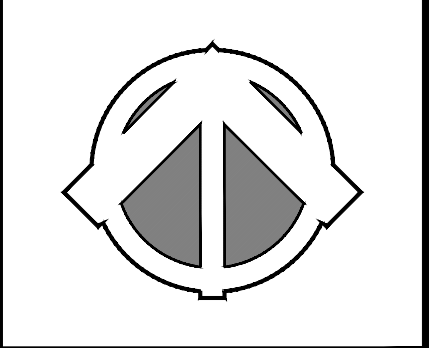

Date: 1/3/23

Revisions:		
Num.	Date	Description
1.	5/3/23	Site lighting plans and lighting specifications


Cottages at Wandering Pond
Athens Lane - Stow, MA





Drawn By: ND Checked By: TM

**Site Lighting
Plan - North**

Scale: 1" = 80'-0"

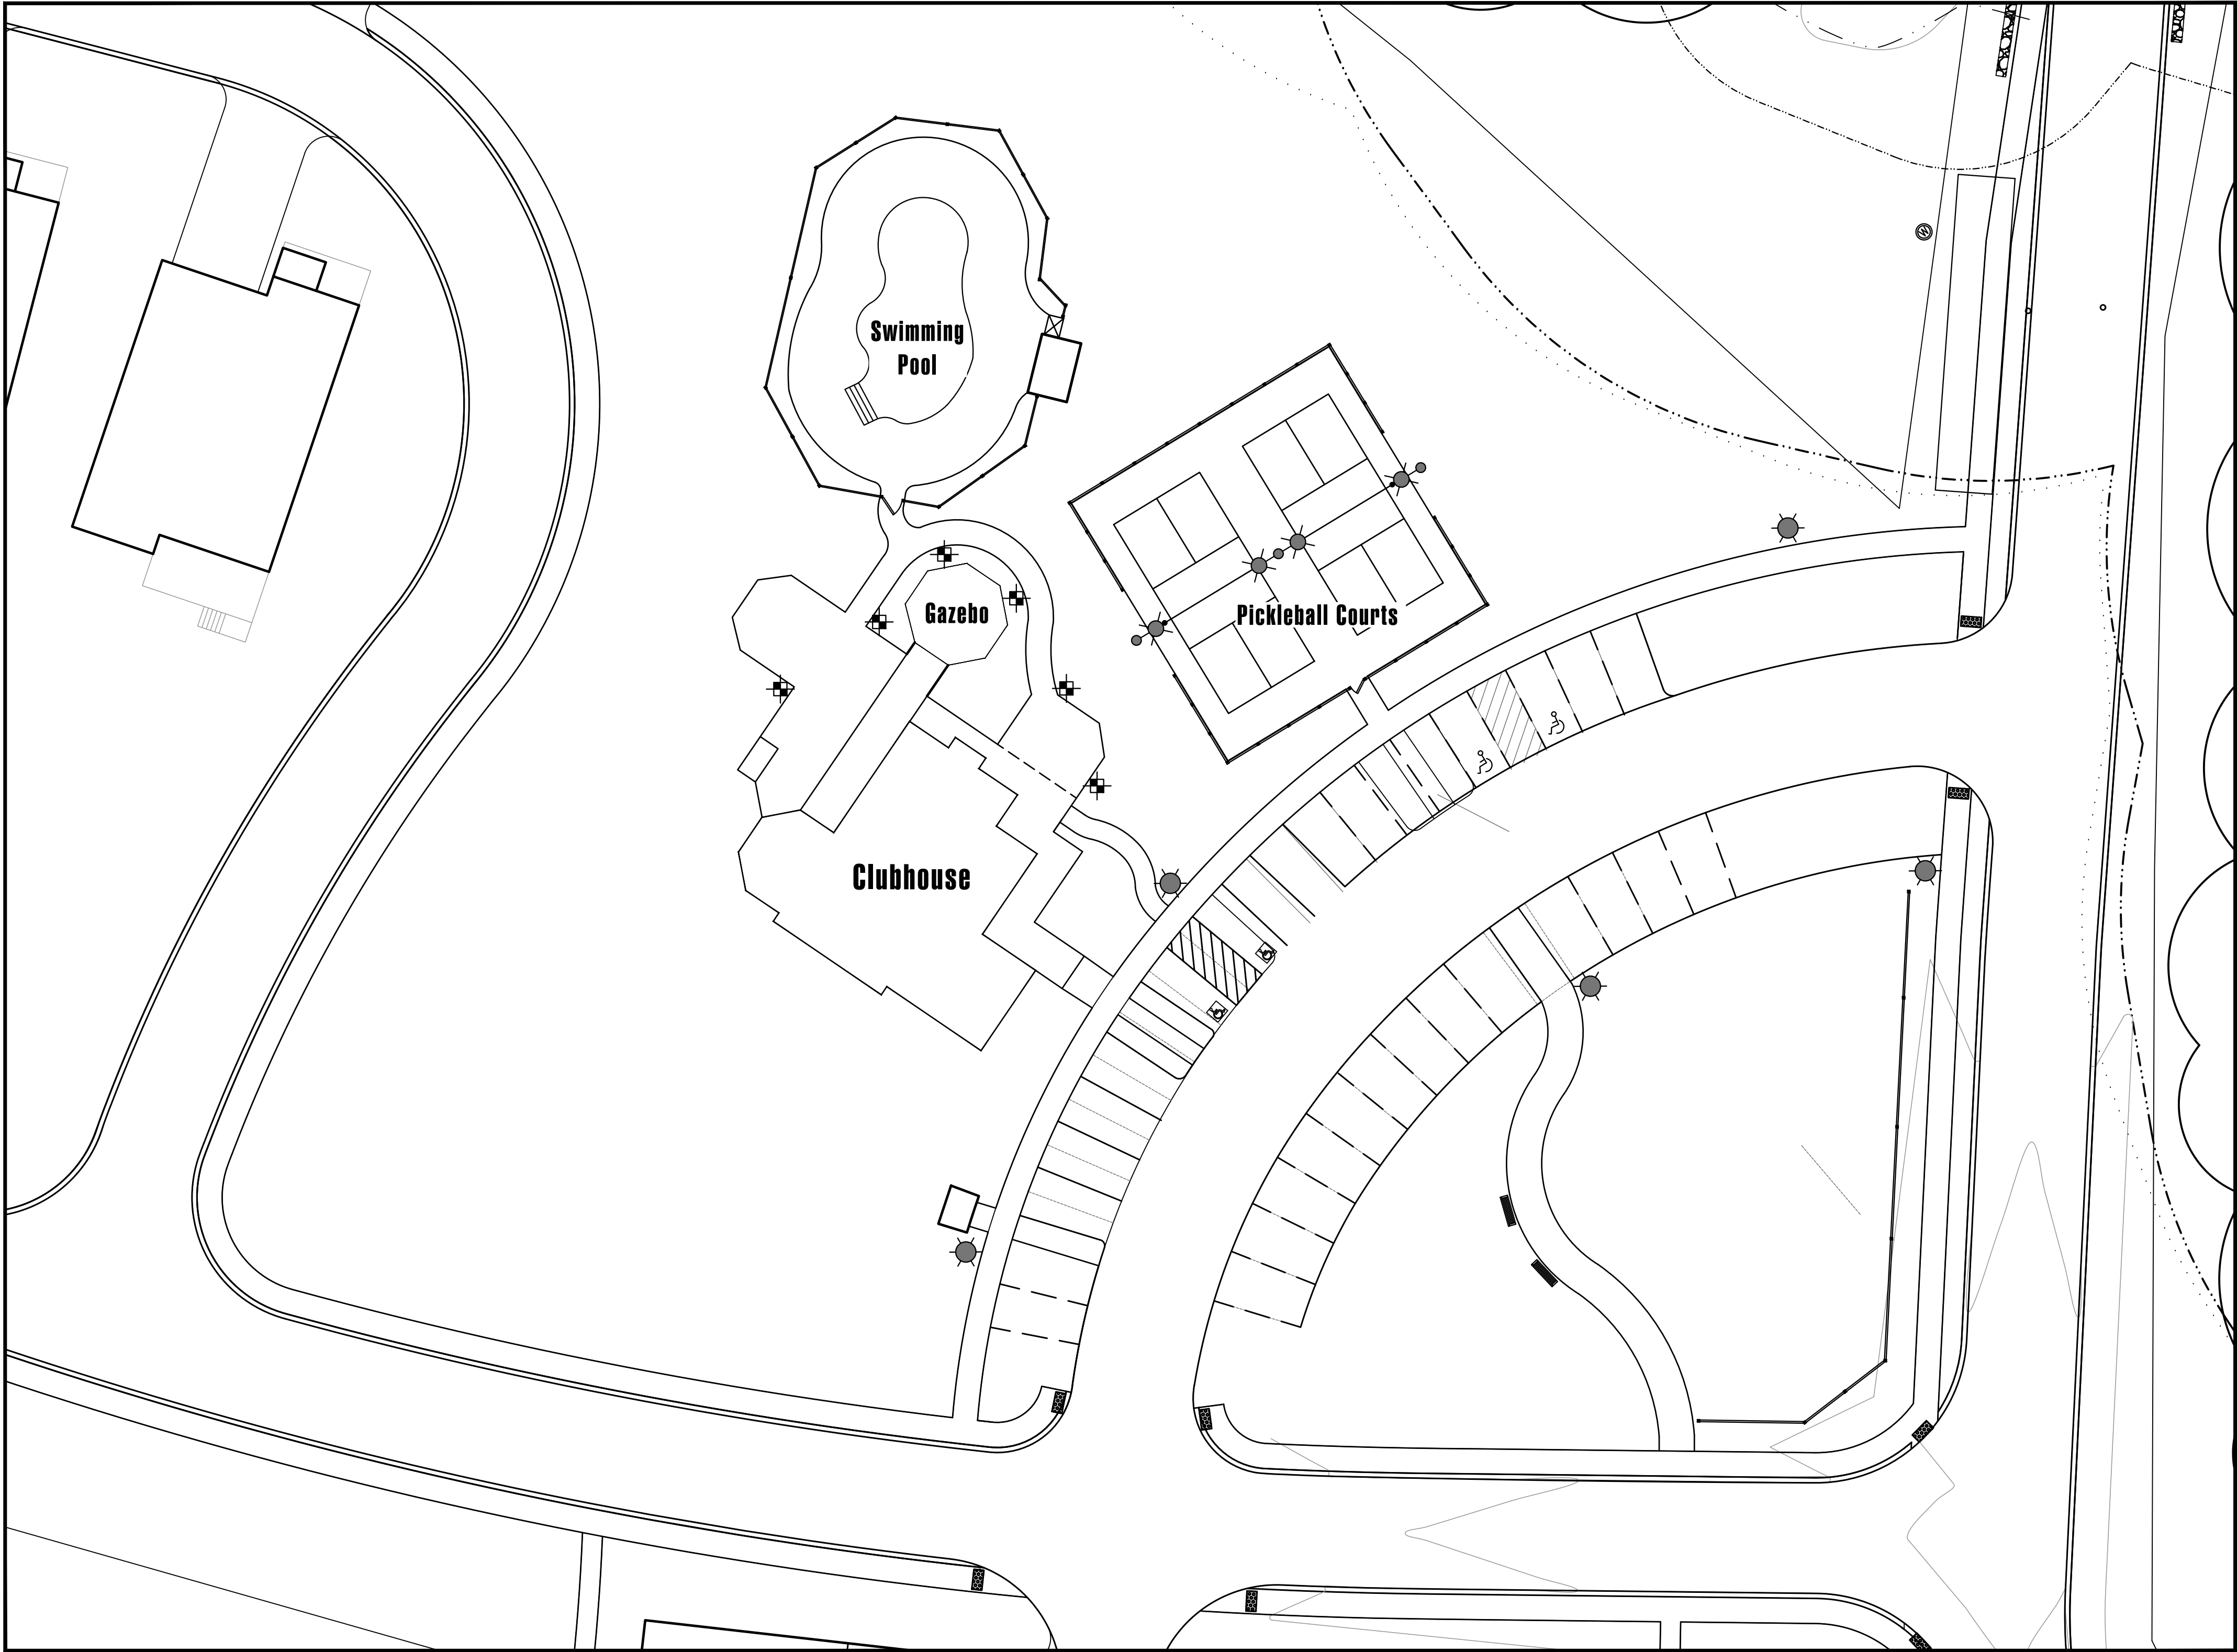Sheet: **L3.2**

 

Lighting Schedule				
SYMBOL	QUANTITY	DESCRIPTION	MANUFACTURER	SPECIFICATION
	5	POST LIGHT	PEMCO	LEXINGTON (SPECIFICATION TBD)
	2	COURT LIGHT	PEMCO	EAGLE (SPECIFICATION TBD)
	1	COURT LIGHT DOUBLE	PEMCO	EAGLE (SPECIFICATION TBD)
	6	BOLLARD LIGHT	ECHO LIGHTING	NUOVA NVA-20W-3K-SMT-TYPE III-BLK



Hawk Design, Inc.
Landscape Architecture
Land Planning
Sagamore, MA
508-833-8800
info@hawkdesigninc.com
www.hawkdesigninc.com

HAWK DESIGN, INC. 2023
THIS DRAWING AND ALL INFORMATION CONTAINED HEREON IS PROPRIETARY INFORMATION OF HAWK DESIGN, INC. AND MAY NOT BE COPIED OR REPRODUCED, EITHER IN WHOLE OR IN PART, BY ANY METHOD, WITHOUT WRITTEN PERMISSION OF HAWK DESIGN, INC.

Date: 1/3/23

Revisions:		
Num.	Date	Description
1.	5/3/23	Site lighting plans and lighting specifications

Cottages at Wandering Pond
Athens Lane - Stow, MA

Drawn By: ND Checked By: TM

**Amenity Area
Lighting Plan**

Scale: 1" = 20'-0"

Sheet: **L3.3**

