

7/28/2023 12:47 PM

Randall Library Renovation + Addition ZBA Application Materials Attachment 9 - Certified Plot Plan July 2023



NOTES

1. THIS DOCUMENT IS AN INSTRUMENT OF SERVICE OF NITSCH ENGINEERING. IT IS ISSUED TO DESIGNLAB ARCHITECTS FOR PURPOSES RELATED DIRECTLY AND SOLELY TO NITSCH ENGINEERING'S SCOPE OF SERVICES UNDER CONTRACT WITH DESIGNLAB ARCHITECTS FOR RANDALL LIBRARY. ANY USE OR REUSE OF THIS DOCUMENT FOR ANY REASON BY ANY PARTY FOR PURPOSES UNRELATED DIRECTLY AND SOLELY TO SAID CONTRACT AND PROJECT SHALL BE AT THE USER'S SOLE AND EXCLUSIVE RISK AND LIABILITY, INCLUDING LIABILITY FOR VIOLATION OF COPYRIGHT LAWS, UNLESS WRITTEN AUTHORIZATION IS GIVEN THEREFOR BY NITSCH ENGINEERING.
2. THE PURPOSE OF THIS PLAN IS TO SHOW THE PROPOSED ADDITIONS TO RANDALL LIBRARY.
3. HORIZONTAL COORDINATES REFER TO MASSACHUSETTS STATE PLANE (NAD 83) BASED ON RTK GPS OBSERVATIONS.
4. PROPOSED ADDITION LOCATIONS AND BUILDING DIMENSIONS PROVIDED BY DESIGN LAB ARCHITECTS AS SHOWN ON RANDALL LIBRARY LOWER LEVEL FLOOR PLAN DATED 06/02/2023 AND STAMPED BY BENJAMIN D. YOUTZ.
5. THE INFORMATION CONTAINED ON THE DISK OR ELECTRONIC DRAWING FILE ACCOMPANYING THIS PLAN MUST BE COMPARED TO THE SEALED AND SIGNED HARD COPY OF THE PLAN TO ENSURE THE ACCURACY OF ALL INFORMATION AND TO ENSURE NO CHANGES, ALTERATIONS, OR MODIFICATIONS HAVE BEEN MADE. RELIANCE SHALL NOT BE MADE ON A DOCUMENT TRANSMITTED BY COMPUTER OR OTHER ELECTRONIC MEANS UNLESS FIRST COMPARED TO THE ORIGINAL SEALED DOCUMENT ISSUED AT THE TIME OF THE SURVEY. DUE TO THE CRITICAL NATURE OF SURVEYING, DATA ACQUISITION, AND AUTOCAD PLAN DEVELOPMENT, IF CRITICAL DIMENSIONAL INFORMATION IS NEEDED AND IS NOT SPECIFICALLY SHOWN ON THE ELECTRONIC DRAWING FILE, PLEASE CONTACT NITSCH ENGINEERING.



LEGEND

- ⊙ CATCH BASIN
- ⊙ CABLE TELEVISION MANHOLE
- ⊙ DRAIN MANHOLE
- ⊙ ELECTRIC MANHOLE
- ⊙ MISCELLANEOUS MANHOLE
- ⊙ SEWER MANHOLE
- ⊙ TELEPHONE MANHOLE
- ⊙ WATER MANHOLE
- ⊙ GAS SHUT-OFF
- ⊙ WATER SHUT-OFF
- ⊙ GAS GATE
- ⊙ WATER GATE
- ⊙ IRRIGATION CONTROL VALVE
- ⊙ ICV
- ⊙ CLEANOUT
- ⊙ BOSTON WATER WORKS
- ⊙ FIRE HYDRANT
- ⊙ DOWN SPOUT
- ⊙ UTILITY POLE
- ⊙ UTILITY POLE WITH CONDUIT LINE TO GROUND
- ⊙ LIGHT POLE
- ⊙ LB
- ⊙ LL
- ⊙ HH
- ⊙ TC
- ⊙ MP
- ⊙ CP
- ⊙ PM
- ⊙ S
- ⊙ TMA
- ⊙ TRSG
- ⊙ PED
- 12" ⊙ DECIDUOUS TREE WITH TRUNK DIAMETER
- 12" ⊙ CONIFEROUS TREE WITH TRUNK DIAMETER
- 60x43 HANDICAP PARKING
- CLF SPOT ELEVATION
- BB CHAIN LINK FENCE
- SGC BITUMINOUS CONCRETE BERM
- VGC SLOPED GRANITE CURB
- VCC VERTICAL GRANITE CURB
- WCR VERTICAL CONCRETE CURB
- LST WHEELCHAIR RAMP
- LST LANDSCAPE TIMBER
- = RIM ELEVATION EQUALS
- = INVERT ELEVATION EQUALS
- = TH= TOP OF HOOD ELEVATION EQUALS
- = NPV NO PIPES VISIBLE
- = TOW= TOP OF WATER
- = CNA CANNOT ACCESS
- = TCB TRAFFIC CONTROL BOX
- = ULD UNDERGROUND LOOP DETECTOR
- = DWP DETECTABLE WARNING PANEL
- = 60x43TW TOP OF WALL ELEVATION
- = CATV UNDERGROUND CABLE TELEVISION LINE
- = E UNDERGROUND DRAIN LINE
- = UNDERGROUND ELECTRIC LINE
- = S UNDERGROUND GAS LINE
- = T UNDERGROUND SEWER LINE
- = UNDERGROUND TELEPHONE LINE
- = W UNDERGROUND WATER LINE
- = OHW OVERHEAD WIRES
- = ⊕ MONITORING WELL
- = BENCH MARK


LEGEND

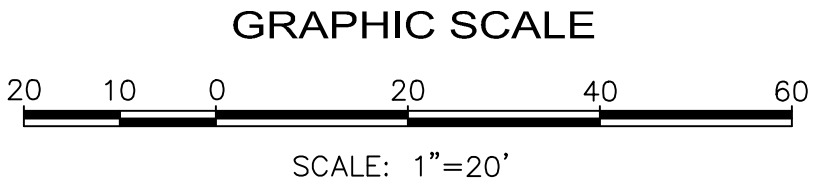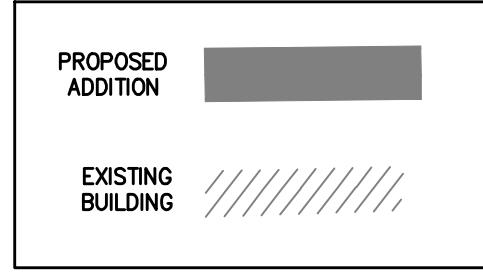

MASSACHUSETTS STATE PLANE COORDINATE SYSTEM
NAD 83

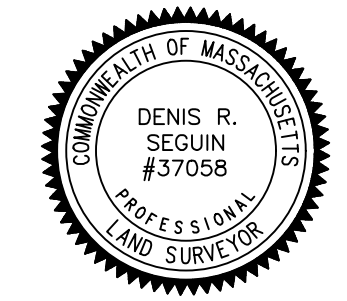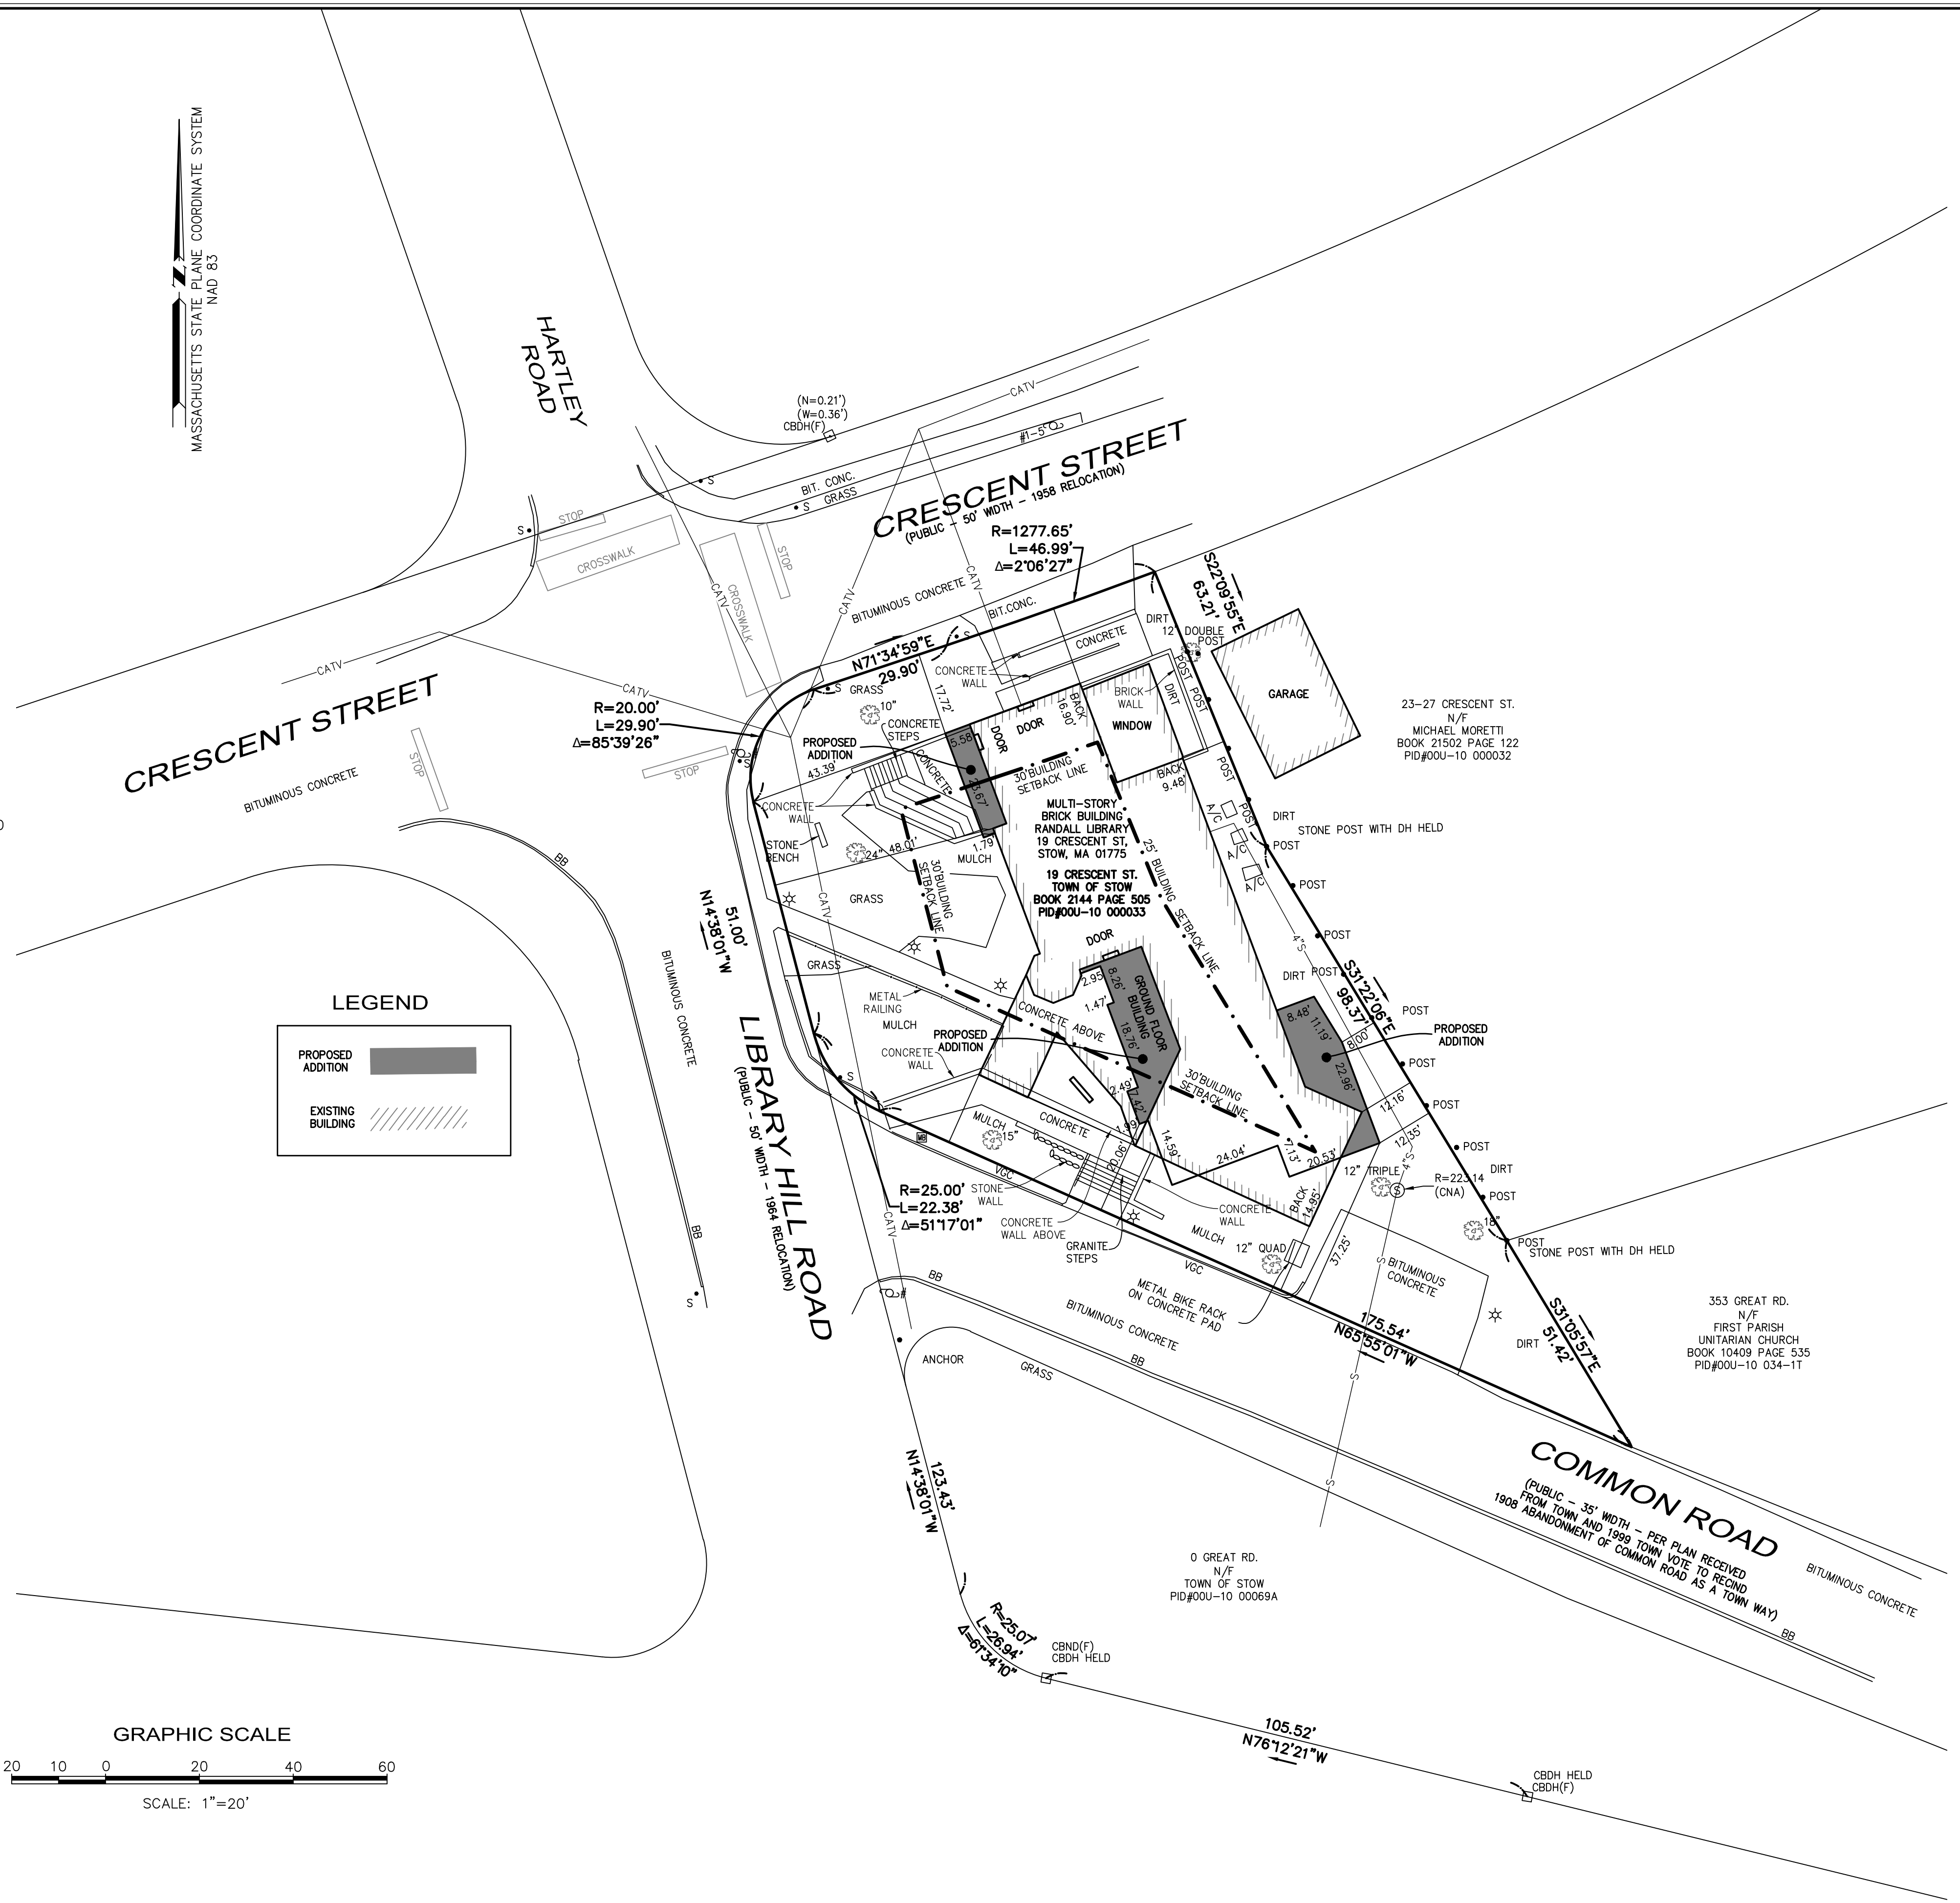

Denis Seguin 7/28/23
 DENIS R. SEGUIN, PLS DATE
 MASSACHUSETTS REG. No. 37058
 REGISTERED PROFESSIONAL LAND SURVEYOR

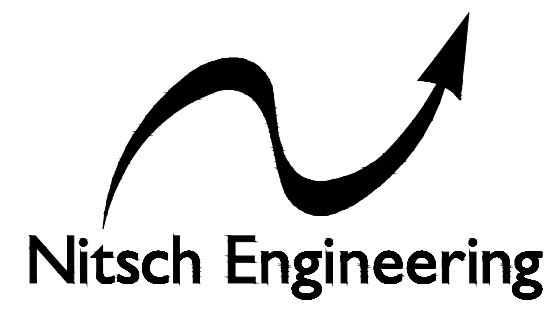

www.nitscheng.com
 2 Center Plaza, Suite 430
 Boston, MA 02108
 T: (617) 338-0063
 F: (617) 338-6472

- ▶ Civil Engineering
- ▶ Land Surveying
- ▶ Transportation Engineering
- ▶ Structural Engineering
- ▶ Green Infrastructure
- ▶ Planning
- ▶ GIS

PROJECT # 14631.1
 FILE: 14631.1_CPP.dwg
 SCALE: 1"=20'
 DATE: JULY 2023
 PROJECT MANAGER: DRS
 FIELD BOOK: 831
 DRAFTED BY: J TJ
 CHECKED BY:

REV.	COMMENTS	DATE

CERTIFIED PLOT PLAN
 RANDALL LIBRARY
 19 CRESCENT ST, STOW, MA 01775
 PREPARED FOR:
DESIGNLAB ARCHITECTS
 35 CHANNEL CENTER STREET, SUITE 103, BOSTON, MA 02210

SHEET: 1
CPP
 OF 1 REV.

p:\10000-14631.1\concord\lib_surf\barney\14631.1_cpp.dwg